


- Notes**
- All dimensions are shown in metres unless noted otherwise.
  - Do not scale from this drawing.
  - The site layout is indicative only and is likely to change as information becomes available.
- Legend**
- Planning Boundary
  - Area Excluded From Planning Boundary
  - Access Track
  - Access Track - Secondary Access for Emergency Use Only
  - Construction Compound
  - Access Gate - Palisade Fence
  - Access Gate - Acoustic Fence
  - Site Fence Line - Palisade Fence
  - Site Fence Line - 5m Acoustic Fence
  - Attenuation Basin
  - Proposed Ditch
  - Proposed Swale
  - Box Culvert
  - Indicative Cable Route
  - Landscaping/Planting

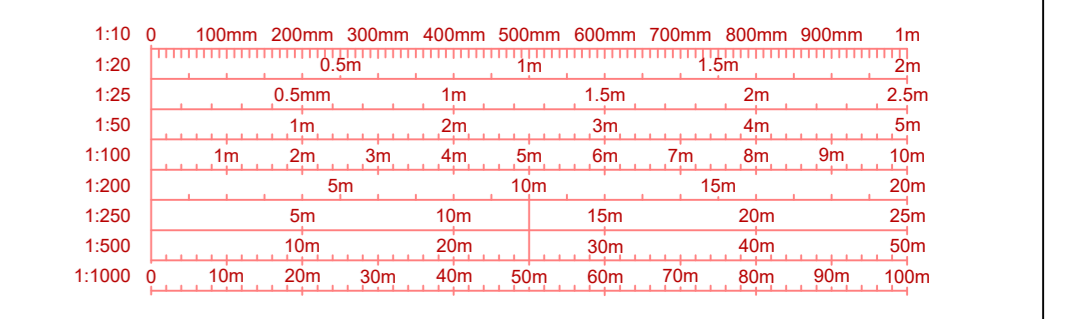

REV	DATE	DESCRIPTION	BY	CHKD
8	06.11.2024	Option area and Option area (secondary) removed. Planning boundary added.	JH	RS
7	10.10.2024	Substation compound amended to block. Box culvert length amended.	JH	AP
6	03.10.2024	Fencing amended.	JH	JH
5	01.10.2024	Emergency access route amended. Substation compound and access amended.	JH	JH
4	13.09.2024	Site layout amended. T2 compound not required and BESS compound amended.	JH	AP
3	12.08.2024	Earthworks amended. Outfall and storm fence lines amended to fit available fence.	JH	AP
2	05.07.2024	Layout amended to suit revised earthworks strategy and design.	JH	AP
1	14.05.2024	Layout amended to Surgeon BESS, indicative cut and fill shown, drainage added and proposed option area added.	JH	AP
0	06.03.2024	Detailed Site Plan - Original	JH	AP

**Field**  
 Fora Montacute Yards  
 186 Shoreditch High Street  
 London  
 E1 6HU


PROJECT: Corriemollie

TITLE: Detailed Site Plan  
 200MW

DISCIPLINE: DESIGN

DRAWING STATUS: FOR INFORMATION

SCALE	DATE	DRAWN BY	CHECKED BY	APPROVED BY
1:1,000 @ A0	06.03.2024	JH	AP	RS
PROJECT NO.	DRAWING NO.	REV.		
BTGBCOR01	005.1			08

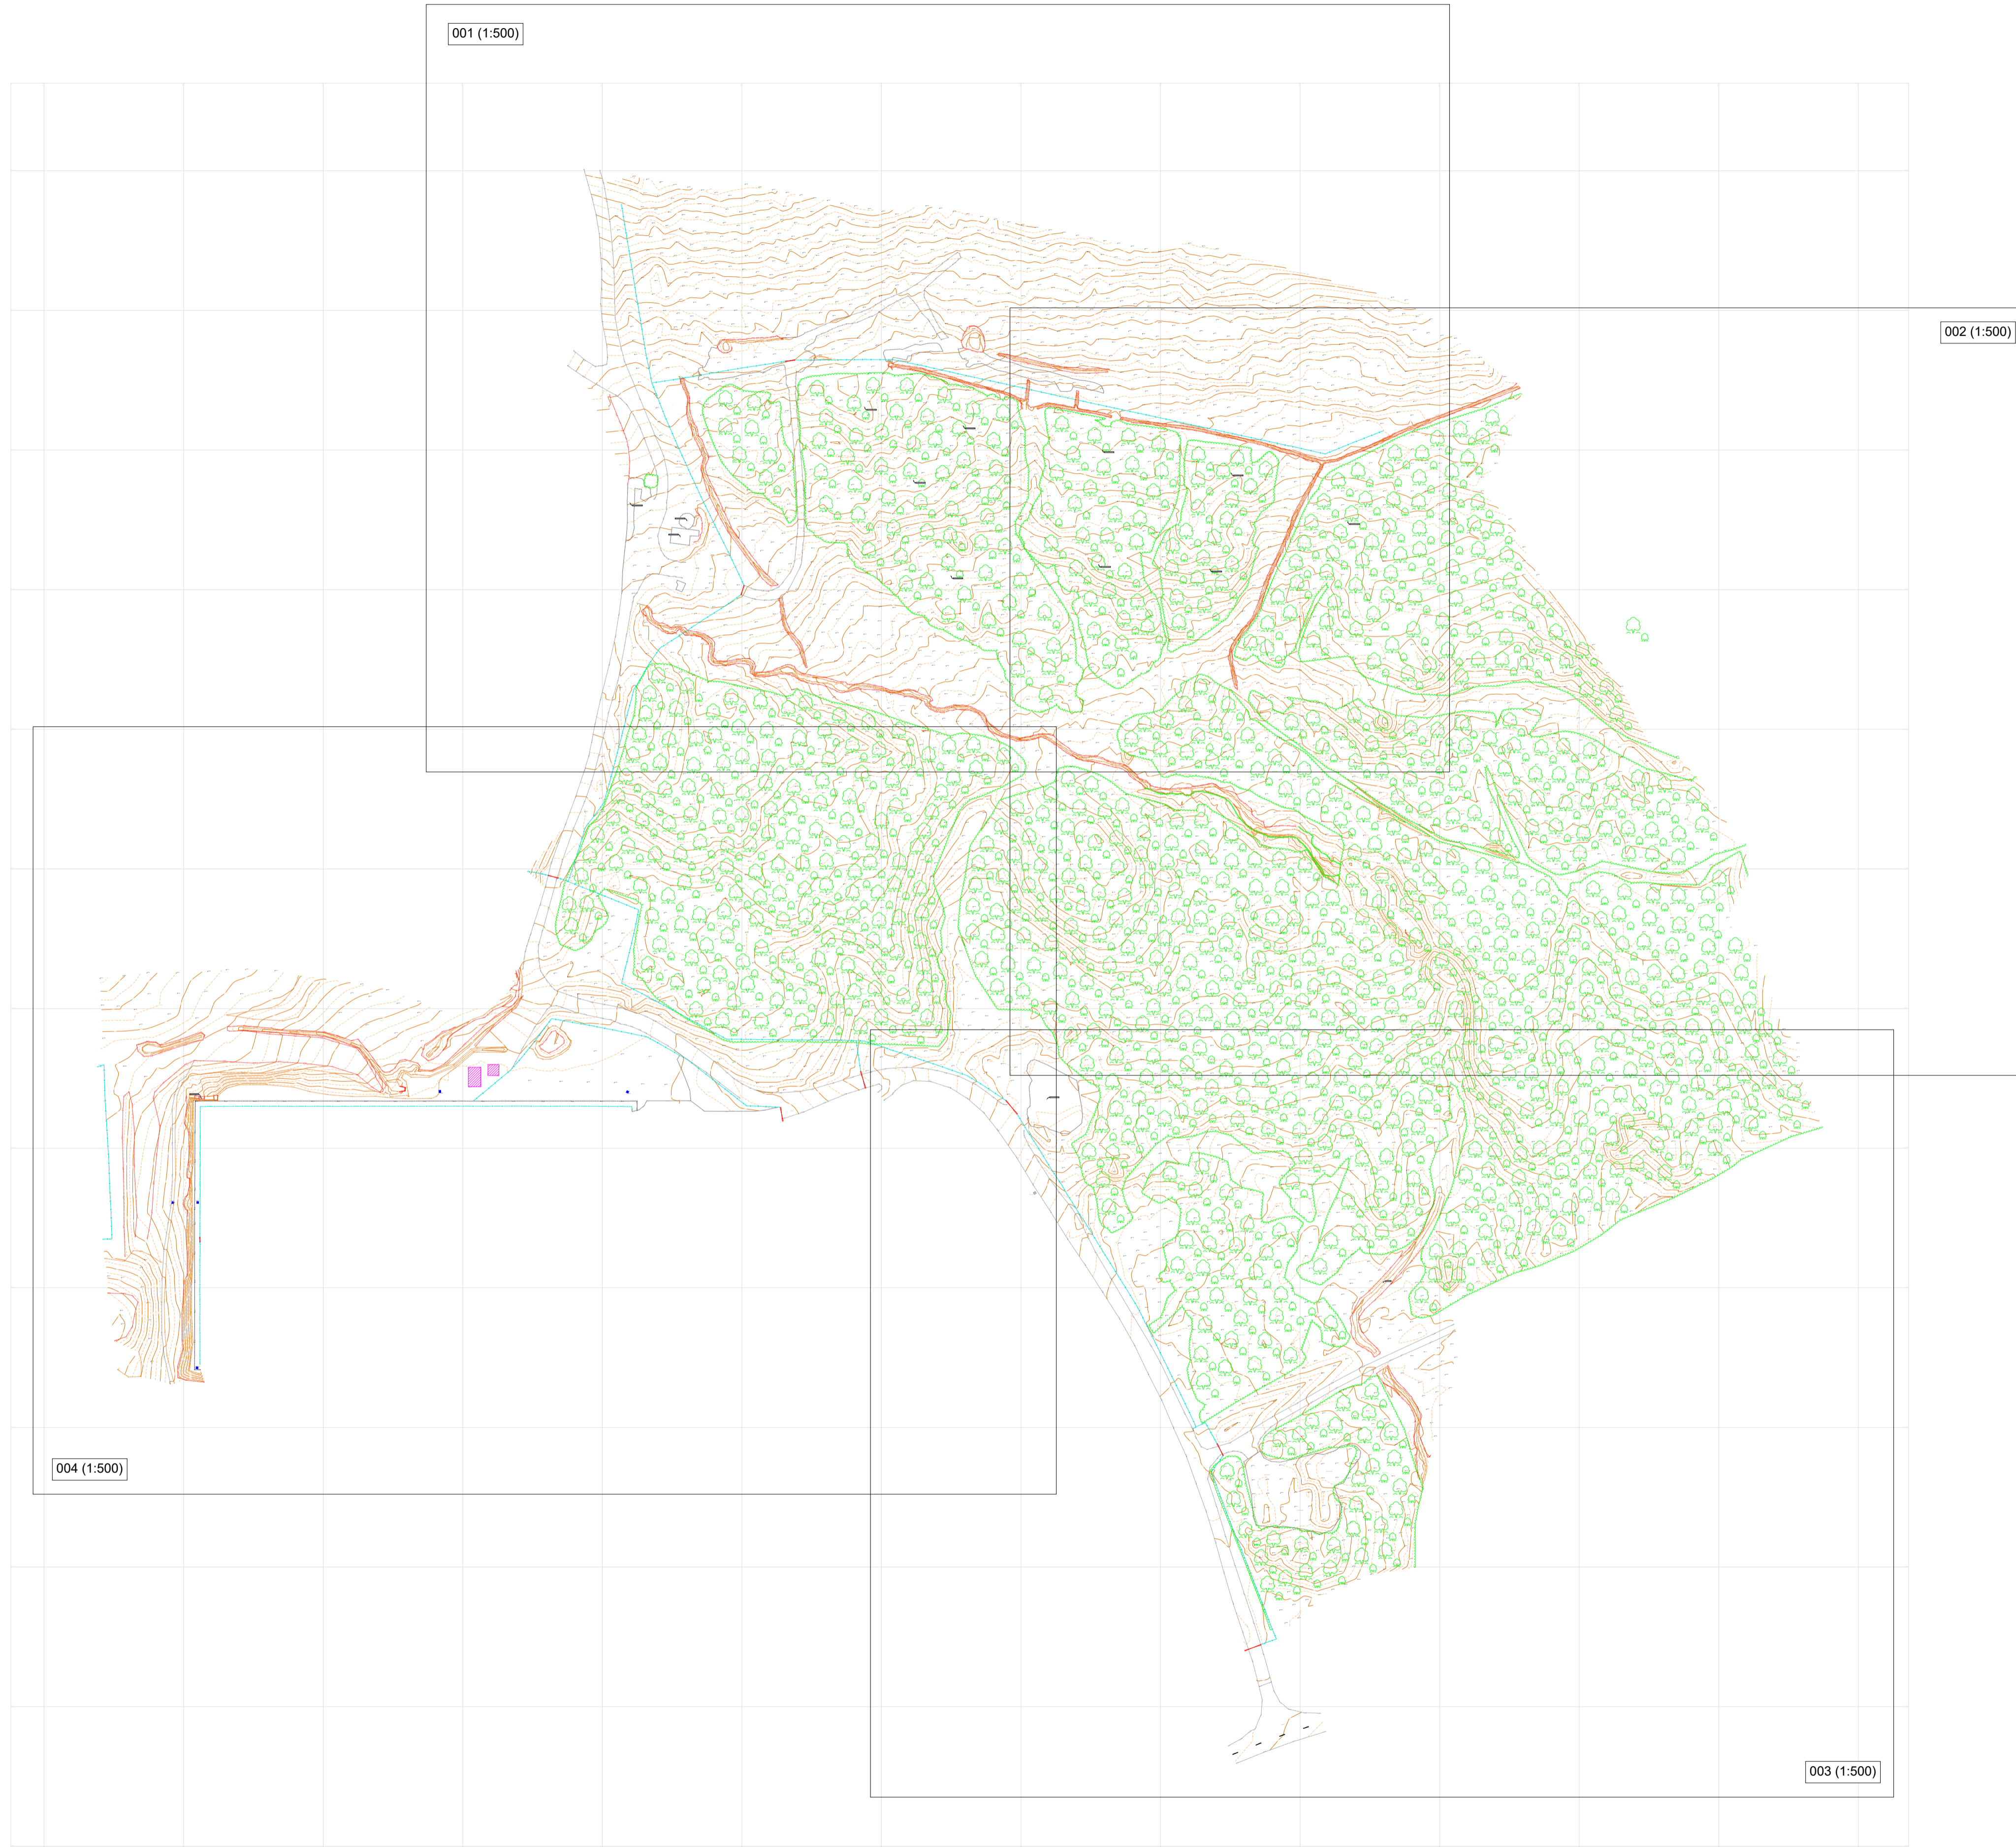

Castle Keep Surveys Drawing Legend

**Topographical Legend**


Drop Kerb	Road
Step	Step
Scarp	Scarp
Public Line	Public Line
Boundary	Boundary
Cloned	Cloned
Concrete	Concrete
Clay Foot	Clay Foot
Block Foot	Block Foot
Foot & Block Foot	Foot & Block Foot
Wooden Foot	Wooden Foot
Top of Bank	Top of Bank
Bottom of Bank	Bottom of Bank
Vertical Line	Vertical Line
Wall	Wall
Footpath	Footpath

**Underground Utility Legend**


E	Electric
GAS	Gas
W	Water
CATV	Cable TV
BT	BT
EMPTY	Empty
URK	URK
OPR	OPR
COM	COM
Field Drain	Field Drain
Asp Drain	Asp Drain
E-TFR	Electric - Taken from Road
E-AR	Armed Electric
OH-E	Overhead Electric
OH-BT	Overhead BT
MSR	Multi-Service Road
W-TFR	Water - Taken from Road
W-AR	Armed Water
GAS-AR	Armed Gas
GAS-TFR	Gas - Taken from Road
Service	Service

**Signposts**

TP	Topograph Pole	CL 100,000	Manhole
LP	Level Post	IL 98,000	Inspection Chamber
EP	Electric Post	CL 100,000	Cable TV Cover
TL	Traffic Light	CL 100,000	BT Cover
FL	Footpath	CL 100,000	PP Cover
CTV	Cable TV C	CL 100,000	Road Gully
SC	Step Gully	CL 100,000	Step Gully
GV	Gas Valve	CL 100,000	Water Meter
BOL	Bol	CL 100,000	Air Valve
2345	Spot Level	CL 100,000	Wash Out
Post	Post	CL 100,000	Free Hub
GUL	Gully	CL 100,000	Gas Valve
ER	Earth Road	CL 100,000	Cable
GFR	Gas Floor	CL 100,000	Electric Lock Pin
RWP	Rain Water Pipe	CL 100,000	LB
RS	Road Sign	CL 100,000	Manhole
SVP	Set Vise Pipe	CL 100,000	Manhole
CH	Chain	CL 100,000	Manhole
CH	Chain	CL 100,000	Manhole
RE	Rebar	CL 100,000	Manhole
LOR	Line of Reflection	CL 100,000	Manhole

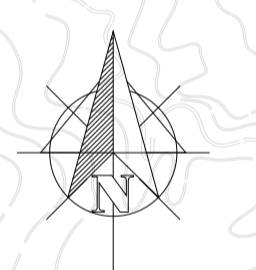

Approximate National Grid North

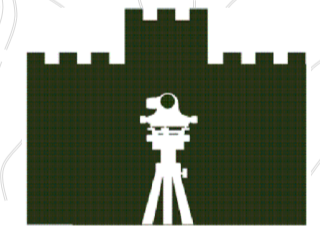

CASTLE KEEP SURVEYS

Corriemollie  
Inverness



Topographical / Lidar Survey

Scale: 1:1250 @ A1 DA

Date: 28/09/2022 MD

Castle Keep Surveys Ltd  
The Keep  
The Village  
Castle Eden  
Corriemollie  
Inverness  
T: 01479 895098  
E: info@castlekeepsurveys.co.uk

Prepared: [ ] Checked: [ ]

Project Number: [ ]

Castle Keep Surveys Drawing Legend

**Topographical Legend**



Drop Kerb	Road
Step	Step
Public Line	Public Line
Boundary	Boundary
Cloned	Cloned
Concrete	Concrete
Chain Fence	Chain Fence
Black Fence	Black Fence
Post & Rail Fence	Post & Rail Fence
Wooden Fence	Wooden Fence
Top of Bank	Top of Bank
Bottom of Bank	Bottom of Bank
Village Line	Village Line
Wall	Wall
Footpath	Footpath

**Underground Utility Legend**


E	Electric
GAS	Gas
W	Water
CATV	Cable TV
BT	BT
EMPTY	Empty
URK	URK
GPR	GPR
COM	COM
Field Drain	Field Drain
Asp Drain	Asp Drain
E-TFR	Electric - Taken from Ground
E-AR	Electric - Above Ground
OHE	Overhead Electric
OH BT	Overhead BT
MSR	Multi-Service Road
W-TFR	Water - Taken from Ground
W-AR	Water - Above Ground
GAS-AR	Gas - Above Ground
GAS-TFR	Gas - Taken from Ground
Service Duct	Service Duct

**Symbols**

TP	Topograph Point	CL 100,000	Manhole
LP	Level Point	CL 98,000	Inspection Chamber
EP	Electric Point	CL 100,000	Cable TV Cover
TL	Traffic Light	CL 100,000	BT Cover
FL	Footpath	CL 100,000	Road Gully
CTV	Cable TV C	CL 100,000	Step Valve
SC	Step Gully	CL 100,000	Water Meter
GV	Gas Valve	CL 100,000	Air Valve
BOL	Bolt	CL 100,000	Wash Out
2345	Spot Level	CL 100,000	Free Hub
Post	Post	CL 100,000	Gas Valve
CU	Cable	CL 100,000	Cabinet
ER	Earth Rod	CL 100,000	Electric Link Box
GFR	Gas Floor	CL 100,000	Manhole
RWP	Road Water Pipe	CL 100,000	Transfer Manhole
RS	Road Step	CL 100,000	Tree
SVP	Set Valve Pipe	CL 100,000	End of Road
CS	Control Station	CL 100,000	
RE	Rebar	CL 100,000	
LOR	Line of Reflection	CL 100,000	

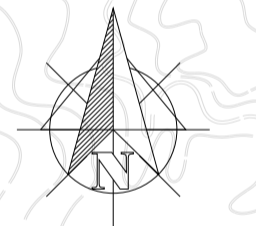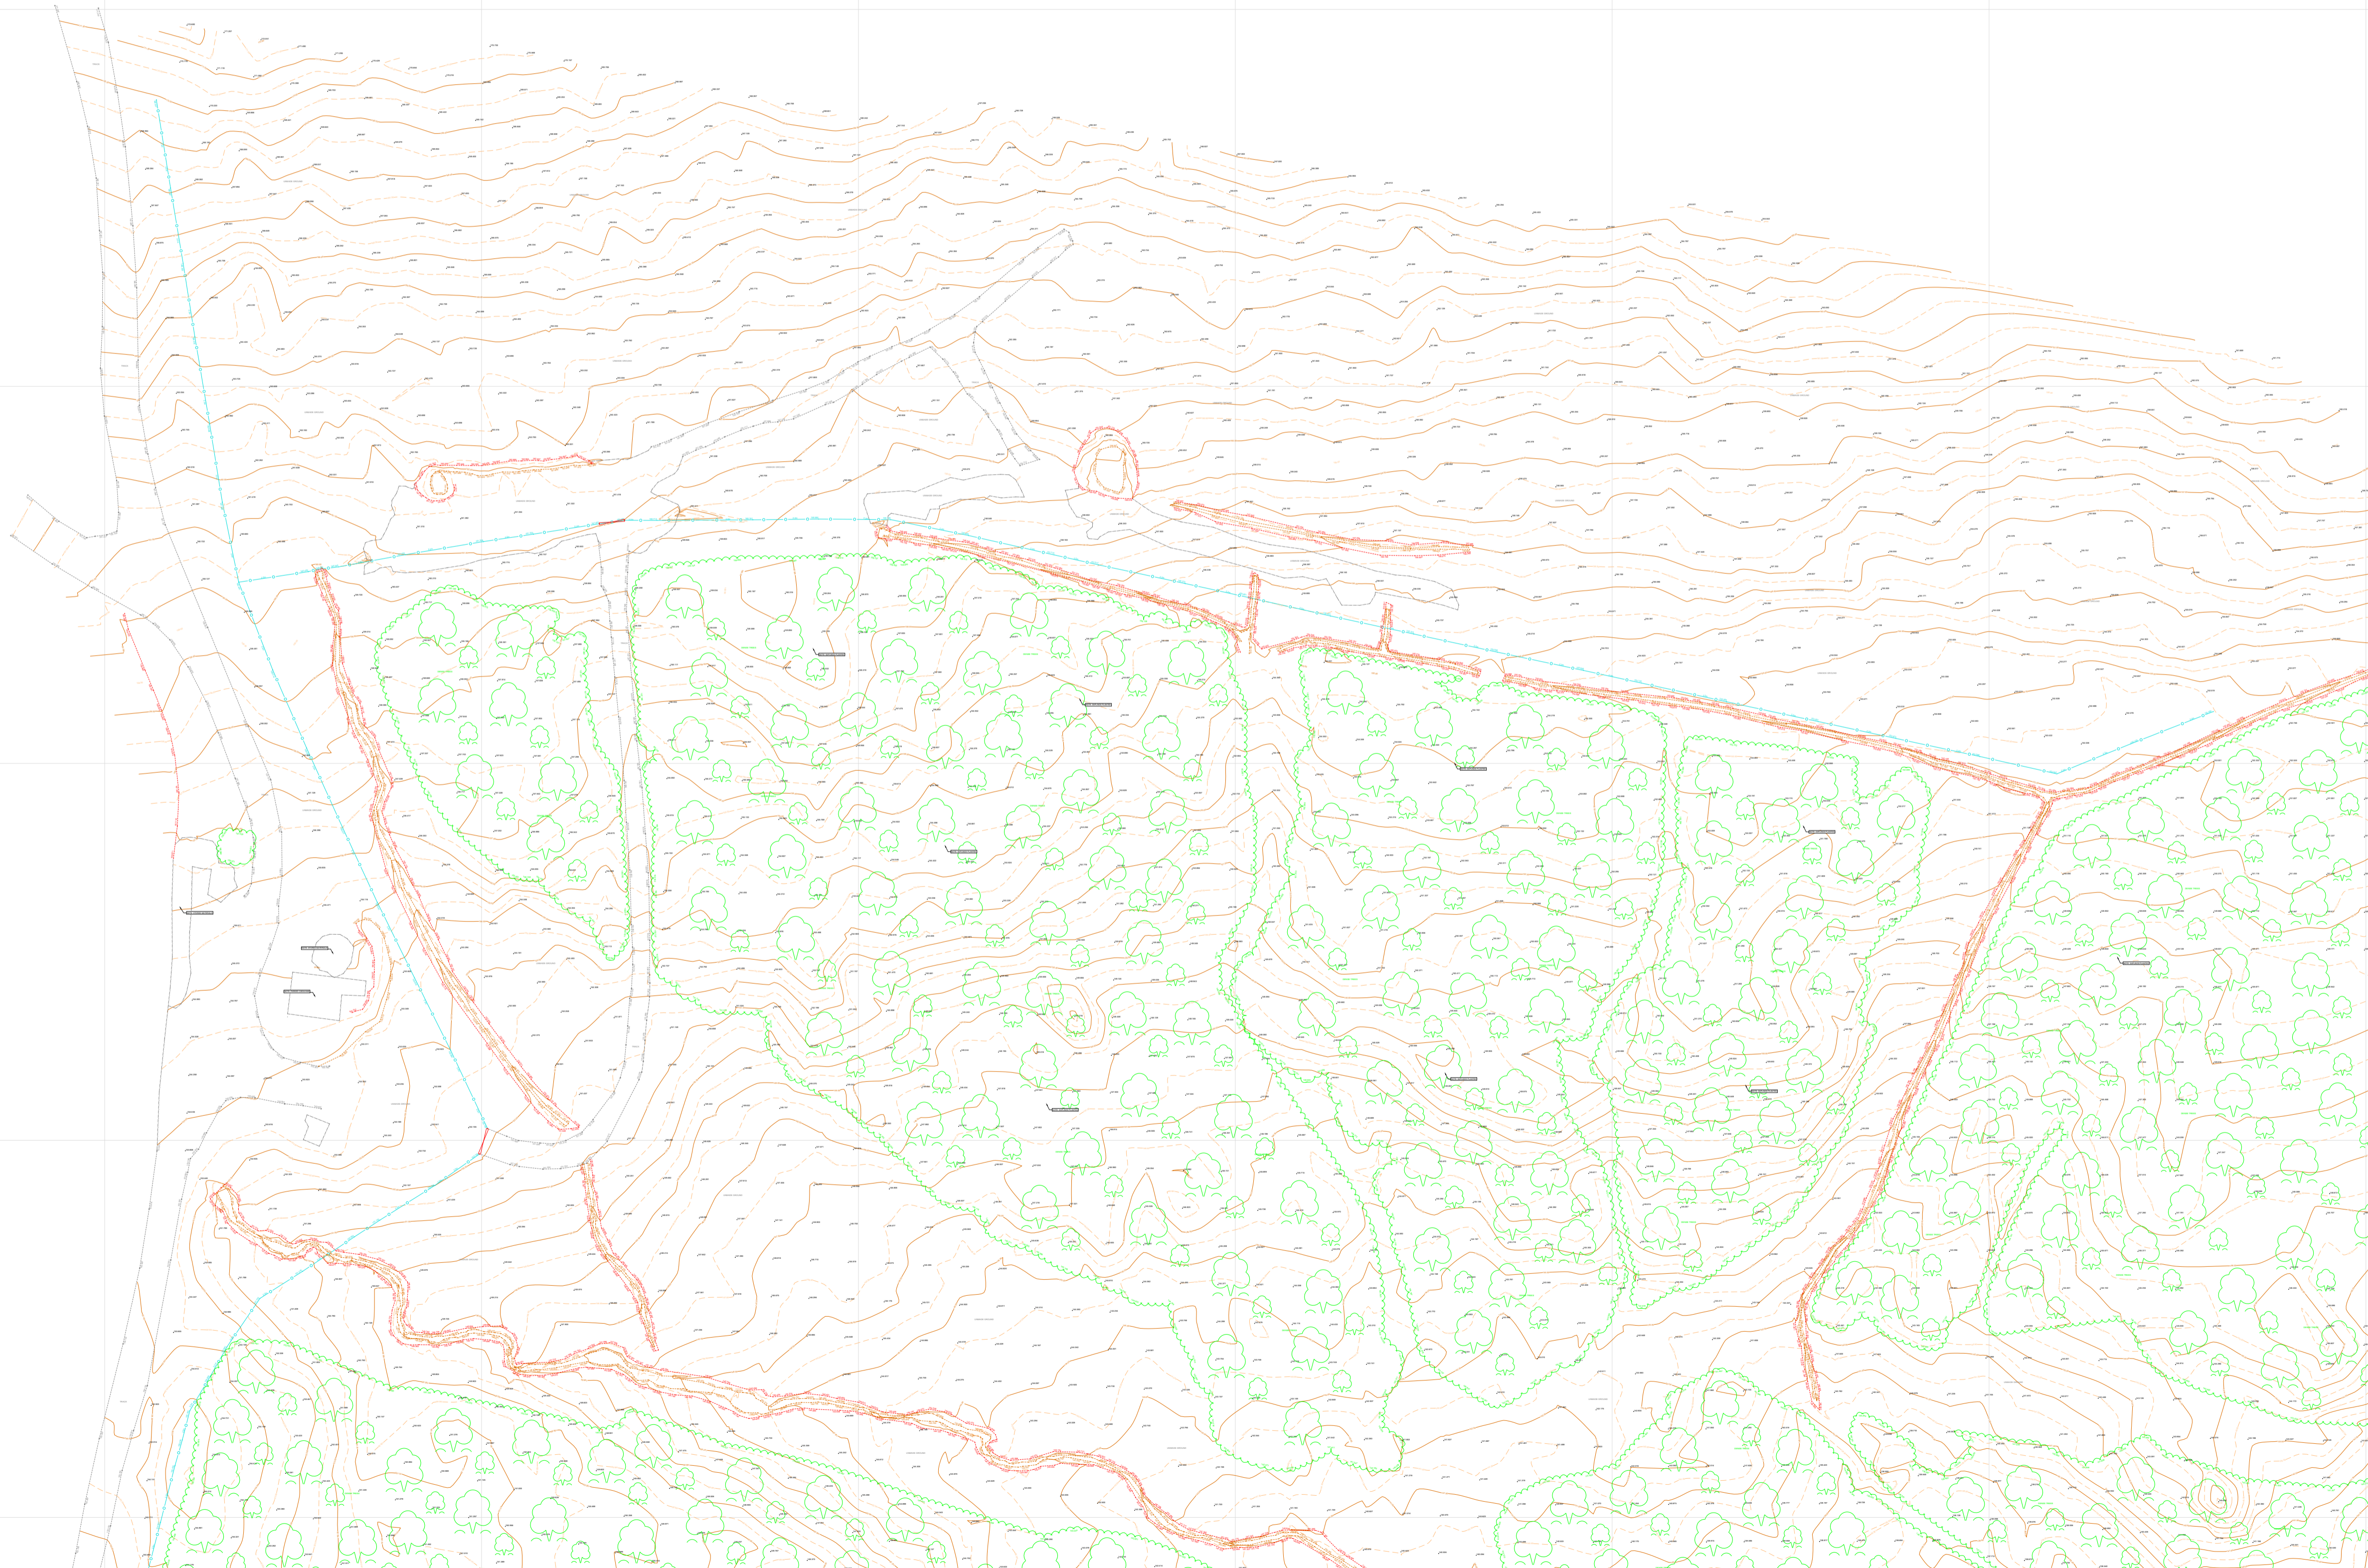

Approximate National Grid North

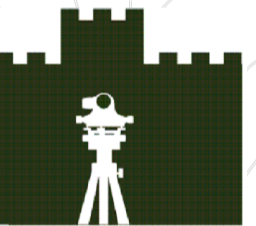

**CASTLE KEEP SURVEYS**

Corriemollie  
Inverness




Topographical / Lidar Survey

Scale	1:500 @ A1	DA
Date	28/09/2022	MD

Castle Keep Surveys Ltd  
The Keep  
The Village  
Castle Eden  
County Durham  
NE22 4LJ  
T: 01429 895098  
E: info@castlekeepsurveys.co.uk

Drawn	Produced	By	Checked
			001



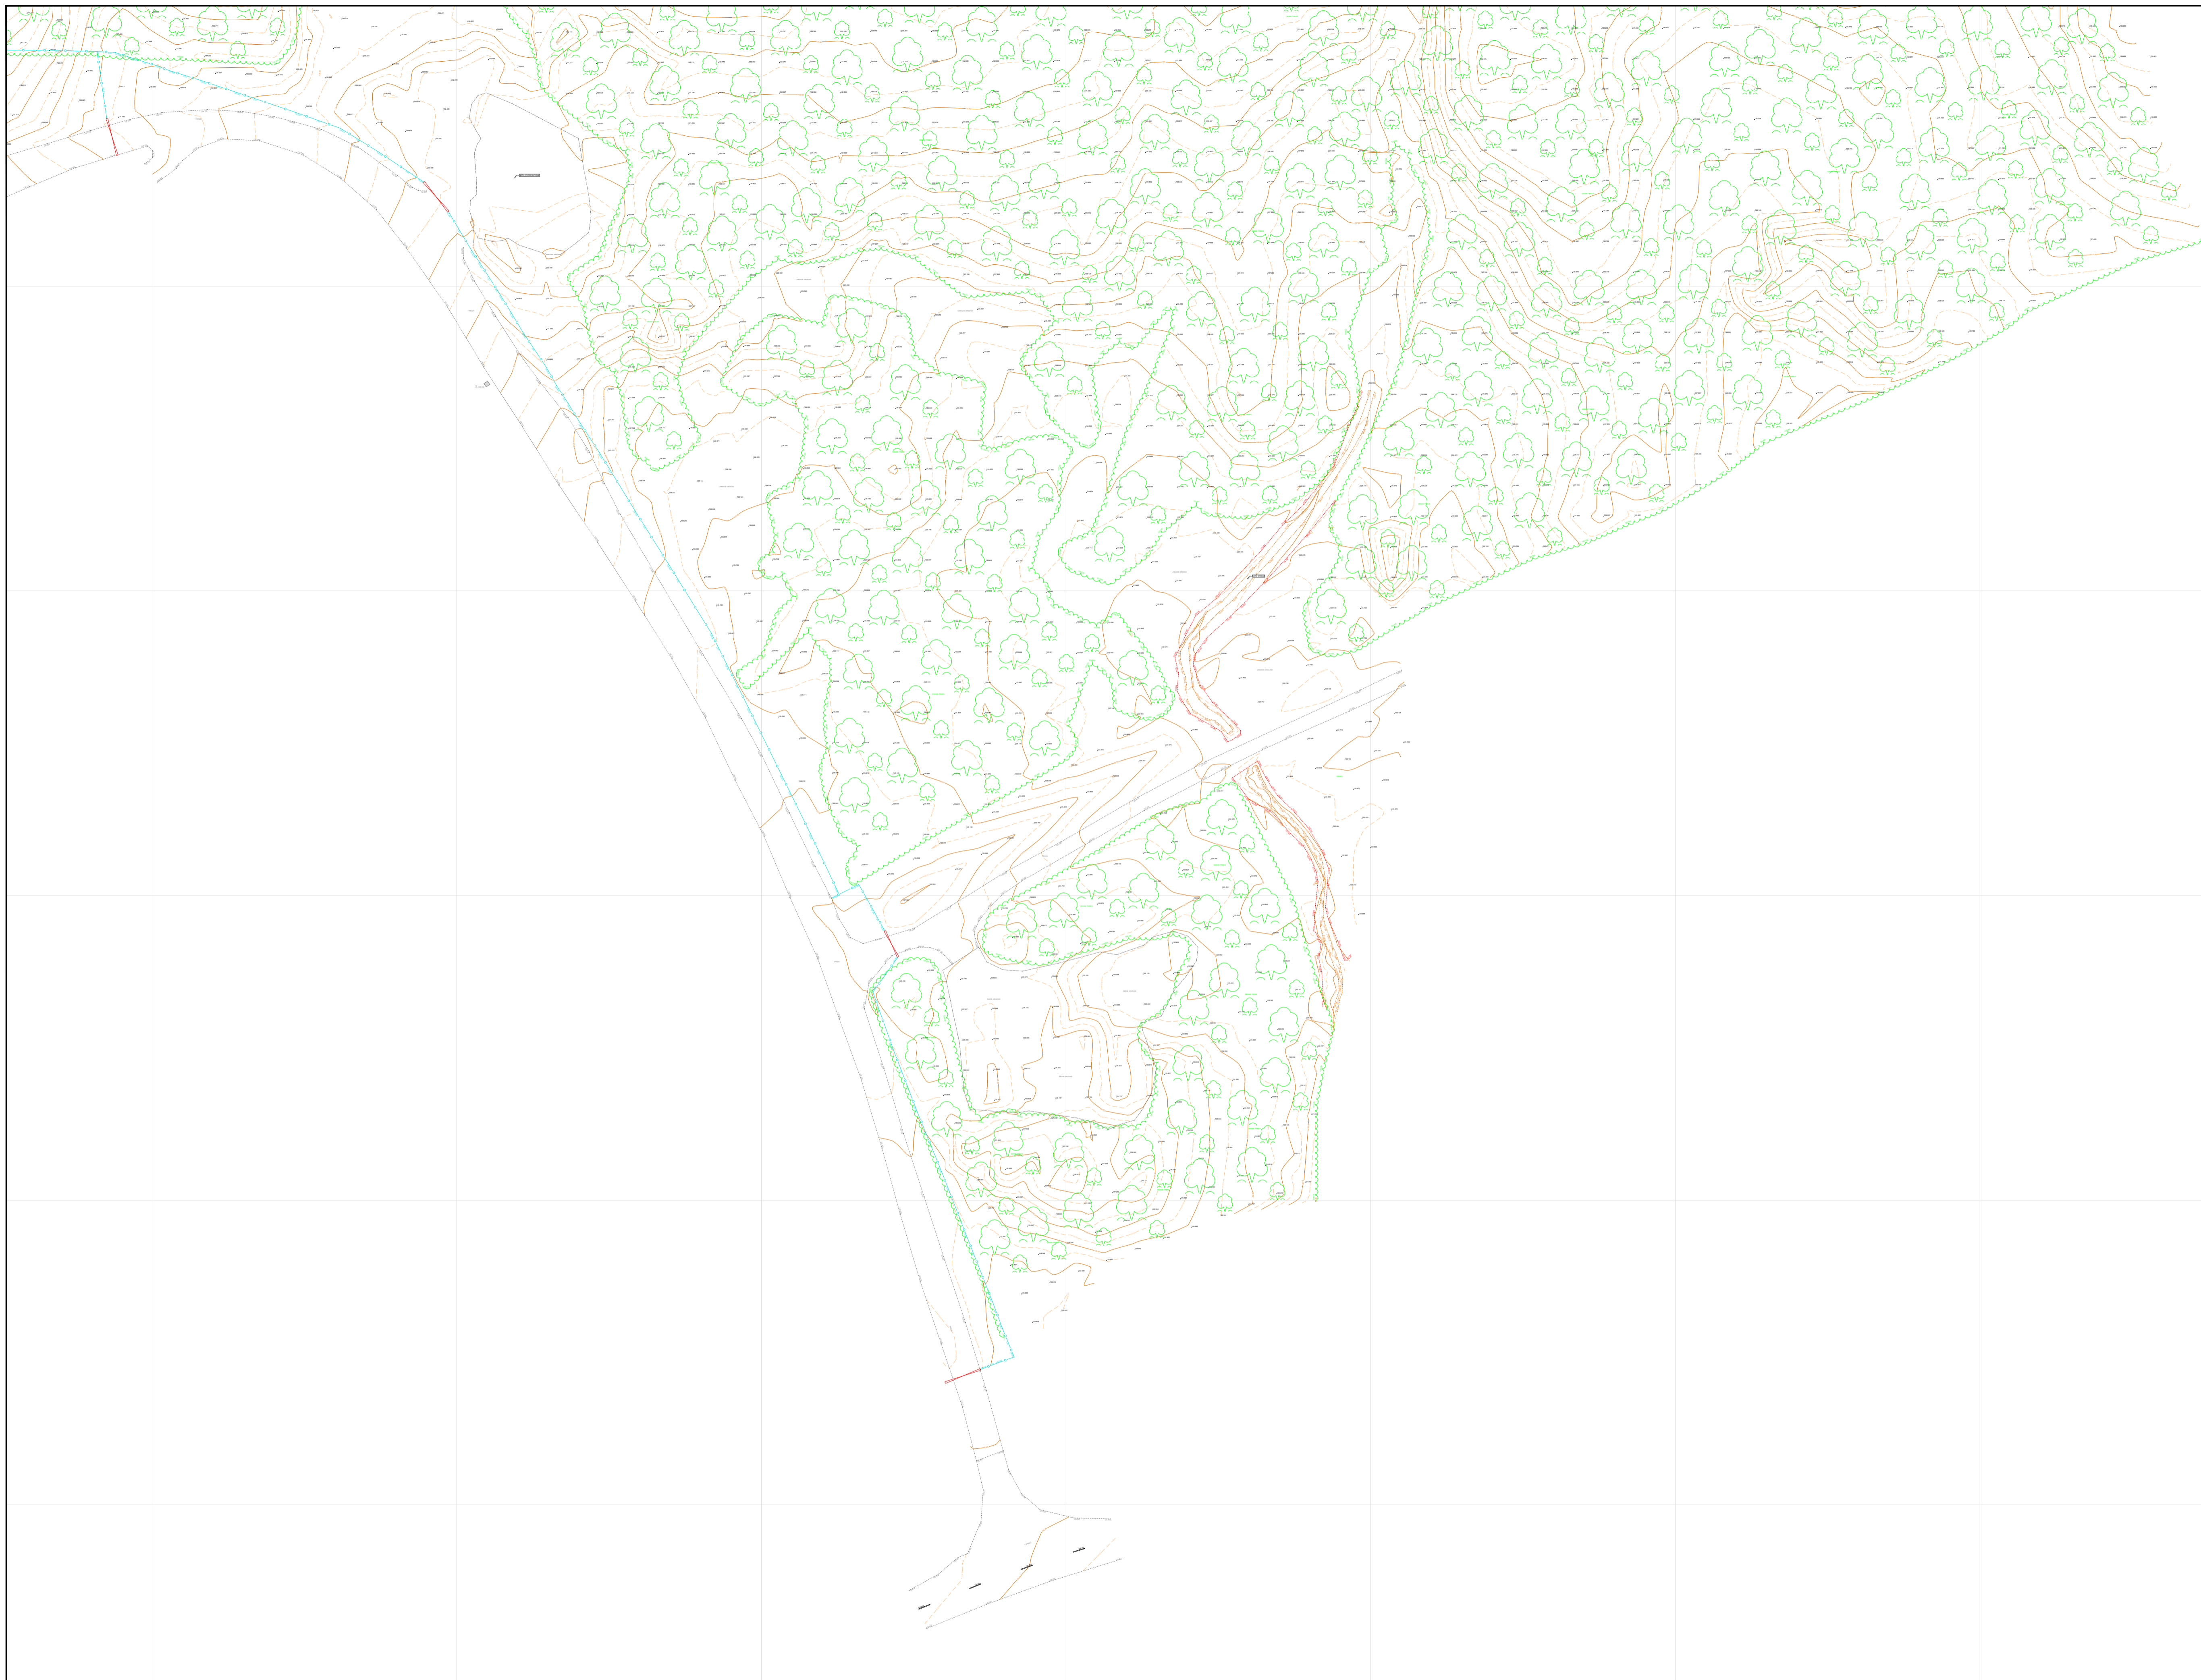

**Castle Keep Surveys Drawing Legend**

**Topographical Features**

- Drop Kerbs
- Step Ecks
- Span
- Pathway Line
- Cloned
- Concrete
- Clash Fence
- Clash Fence
- Post & Rail Fence
- Wooden Fence
- Top of Bank
- Bottom of Bank
- Boundary Line
- Village Line
- Wall
- Footpath

**Underground Utility Line Types**

- E - Electric
- GAS - Gas
- W - Water
- CATV - Cable TV
- CTV - Closed Circuit TV
- BT - British Telecom
- EMPTY - Empty Cables
- UNK - Unknown Utility
- OPR - Open Road Possible Utility
- COM - Communications
- FW - Fuel Water Storage Tank
- SW - Surface Water Storage Tank
- CS - Combined Sewer Storage Tank
- MS - Manhole Storage Tank
- FD - Field Drain
- AD - Access Drain
- E-TFR - Electric - Taken from Road
- E-AR - Armoured Electric
- OHE - Overhead Electric
- OH BT - OH British Telecom
- MSR - Multi-Service Road
- MSF - Multi-Service Fossil
- W-TFR - Water - Taken from Road
- W-AR - Armoured Water
- GAS-AR - Armoured Gas
- GAS-TFR - Gas - Taken from Road
- Service Cables

**Spotlights**

- TP - Topograph Pole
- LP - Lamp Post
- EP - Electric Post
- TL - Traffic Light
- FL - Floodlight
- CTV - Cable TV C
- SC - Step Cask
- GV - Gas Valve
- BOL - Bulb
- 2345 - Spill Level
- Post - Post
- QUL - Gully
- ER - Earth Rod
- GR - Gas Rod
- RWP - Rain Water Pipe
- RS - Road Sign
- SVP - Set Vise Pipe
- OR - Obstacle
- N=546728 511 Level=28.508
- RE - Retaining Edge
- LOR - Line of Reflection
- MM1 - Manhole
- IL 98 000 - Inspection Chamber
- CL 100 000 - Cable TV Cover
- CATV - Cable TV Cover
- BT - BT Cover
- SW - Sewer
- CL 100 000 - Sewer Valve
- WV - Water Valve
- CL 100 000 - Water Meter
- WC - Water Closet
- CL 100 000 - Wash Out
- CL 100 000 - Free Hub
- CL 100 000 - Gas Valve
- CL 100 000 - Cabinet
- CL 100 000 - Cabinet
- LB - Electric Light Pole
- MM2 - Manhole
- CL 100 000 - Sewer
- CL 97 500 - Sewer
- MM3 - Manhole
- CL 100 000 - Sewer
- CL 97 500 - Sewer
- RE - Retaining Edge
- ECOB - End of Road

Approximate National Grid North

**CASTLE KEEP SURVEYS**

Corriemollie  
Inverness

Client Name: **FIELD**

Drawing Title: **Topographical / Lidar Survey**

Scale: 1:500 @ A1

Date: 28/09/2022

Author: DA

Checker: MD

Castle Keep Surveys Ltd  
The Keep  
The Village  
Castle Eden  
Co Durham  
NE22 4JL  
T: 01429 895098  
E: info@castlekeepsurveys.co.uk

Revision: 003